 



no. 3 Sunnyside Lane



Notes: -  
Rev: -

Electrical key	
	Spur
	Socket (low level)
	Socket (high level)
	Switch (1 way)
	External light wall mounted
	Led linear luminaire ceiling mounted
	Emergency light wall mounted
	Ceiling bulkhead fitting
	Presence detector ceiling mounted
	Hand dryer wall mounted
	Ceiling mounted extract fan
	Smoke detector
	Call Point

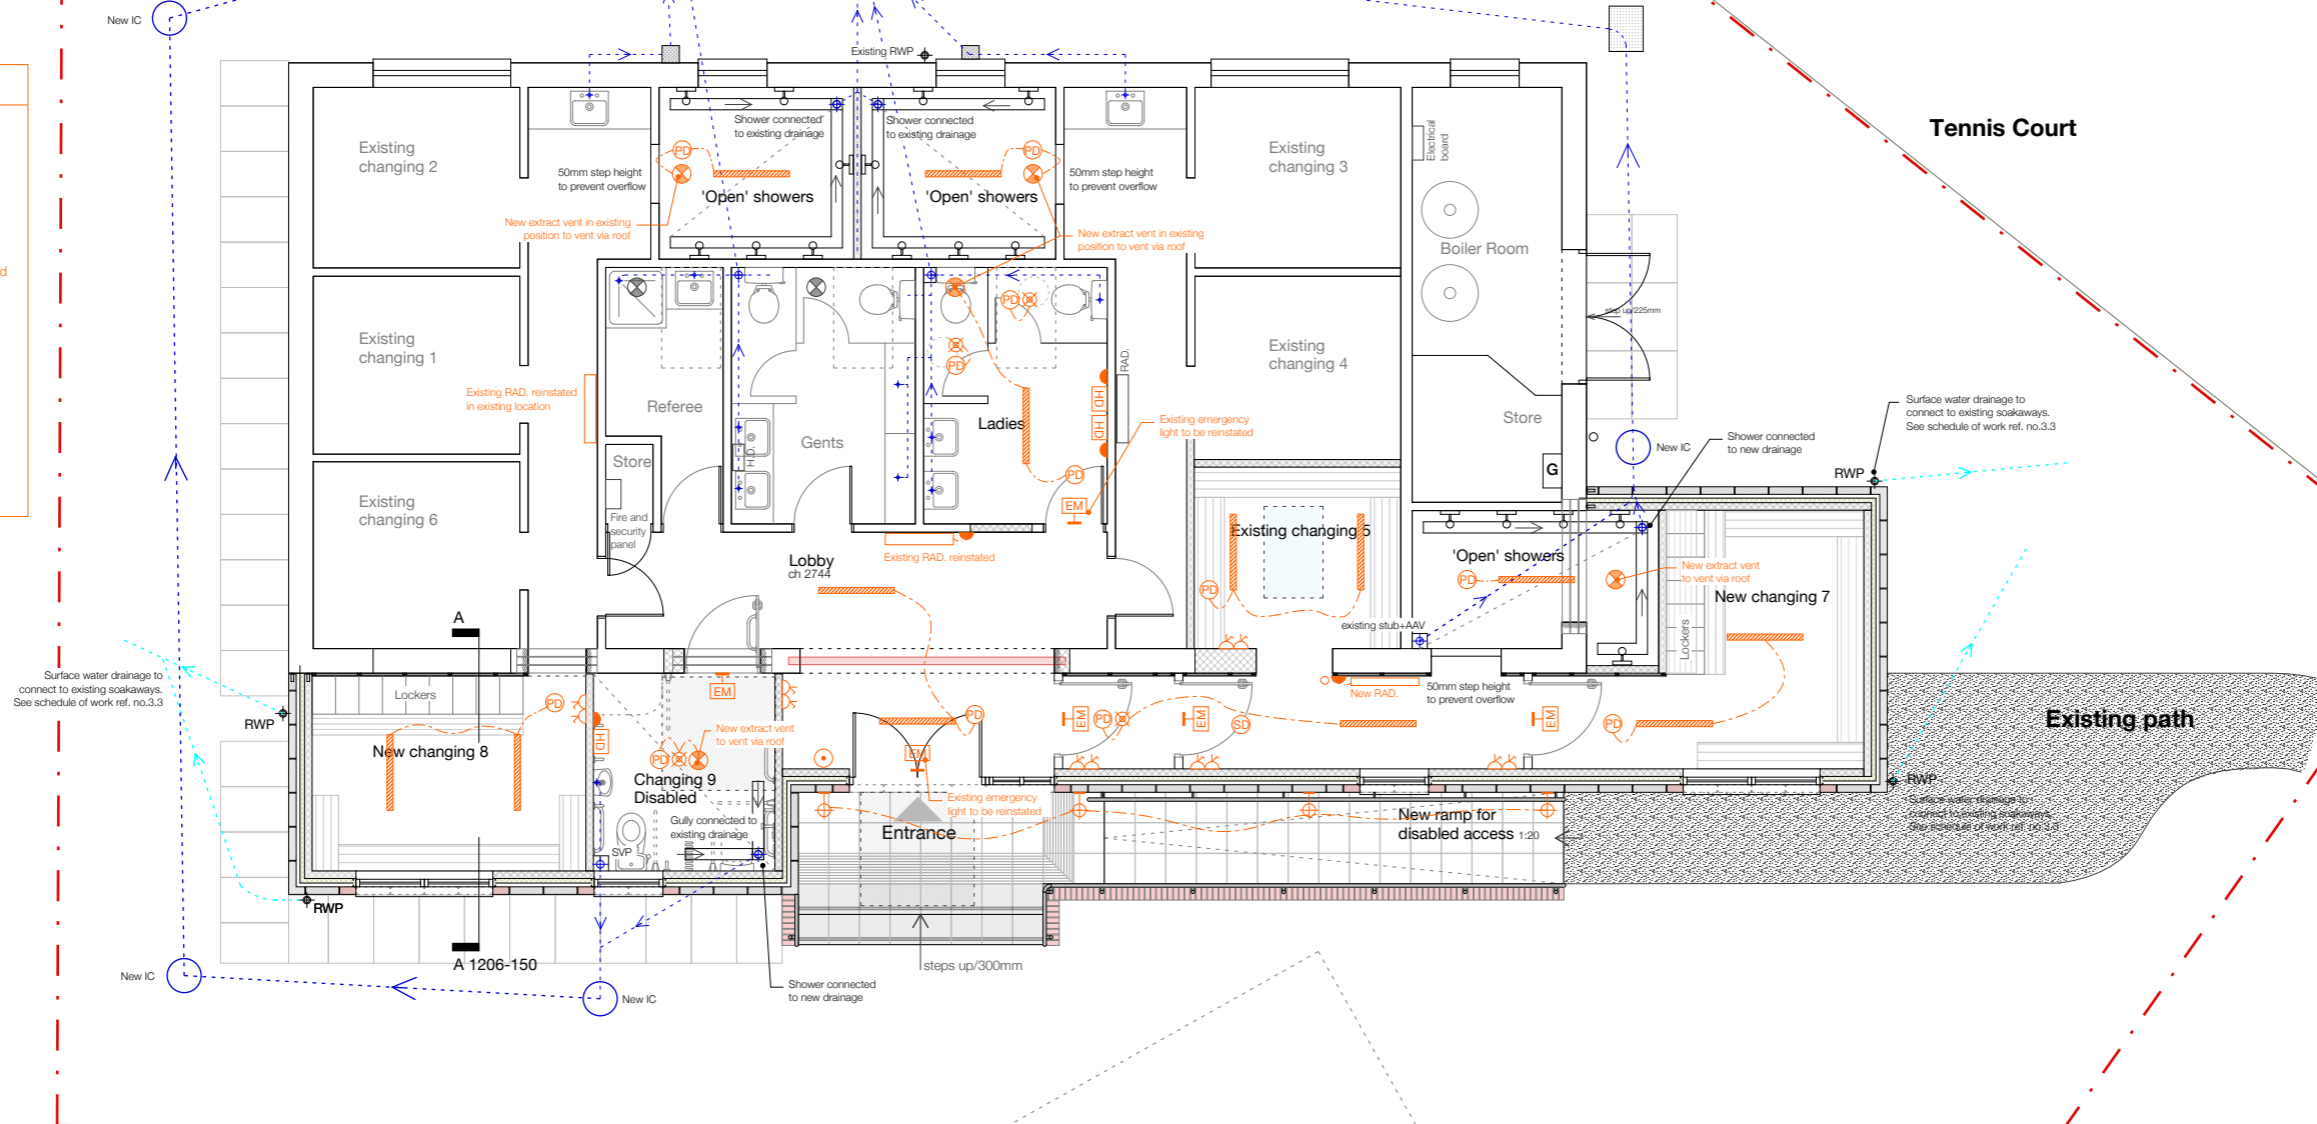

Issue: **Tender Issue**  
 Date: **March 2018**  
 Project: **Sunnyside Sports, Sunnyside Lane, BS37 4PP Yate**  
 Title: **Ground Floor electrical layout and drainage plan**

Drawn: **SI** Checked: **CA**  
 Scale: **1:25 at A1 (1:50 at A3)**  
 Drawing: **1206-141**

**ASKEWCAVANNA**  
 Architects  
 14 Backfields Lane,  
 Bristol BS2 8QW  
 T: 0117 9244606